


Shepley Bulfinch Richardson & Abbott
Architecture / Planning / Interiors / Est. 1874
2 Seaport Lane, Boston, Massachusetts 02110
T: 617.423.1700 F: 617.451.2420
www.ShepleyBulfinch.com

Spiegel Zamecnik & Shah Inc.
54 Wall Street
New Haven, CT 06511
STRUCTURAL ENGINEER
Bard, Rao + Athanas
311 Arsenal Street
Watertown, MA 02472
M.E.P. ENGINEER
Tighe + Bond
1000 Bridgeport Avenue, Floor 3
Shelton, CT 06484
CIVIL ENGINEER
Towers | Golde
85 Willow Street
New Haven, CT 06511
LANDSCAPE ARCHITECT
R.W. Sullivan
529 Main Street, Suite 203
Boston, MA 02129
CODE & REGULATORY

NOTES:
1. REFER TO A901 FOR PARTITION TYPES AND DETAILS.
WALL TYPES TO BE "A3 STUD PARTITION U.N.O."
2. PARTITION TYPES AND DIMENSIONS INCLUDED ON "A"
SERIES DETAIL, INTERIOR ELEVATION KEYS, WALL
PROTECTION AND NOTES INCLUDED ON "B" SERIES PLAN
DRAWINGS
3. REFER TO A912 FOR BORROWED LIGHT, DOOR AND
FRAME TYPES
4. DOORS TO BE LOCATED WITH INSIDE FACE OF JAMB
6" FROM FACE OF ADJACENT WALL U.N.O.
5. DIMENSIONS ARE TO FINISH FACE OF GWB U.N.O.
7. REFER TO INTERIOR ELEVATIONS AND TYPICAL
MOUNTING HEIGHT SHEET FOR LOCATIONS OF
PLUMBING FIXTURES.

--- 1 HOUR FIRE SEPARATION ASSEMBLY
--- 2 HOUR FIRE SEPARATION ASSEMBLY
--- SMOKE BARRIER
--- SMOKE PARTITION

| NO. | DATE | DESCRIPTION | REVISION |
|-----|------|-------------|----------|
|-----|------|-------------|----------|

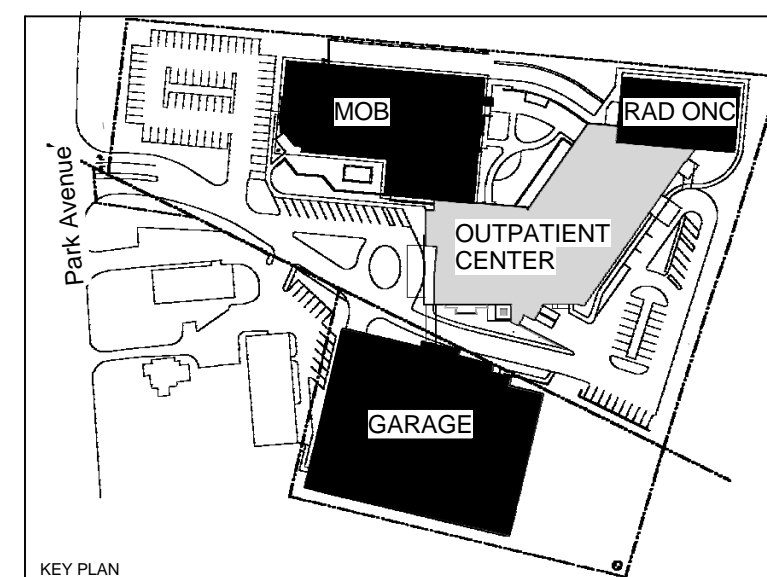


BRIDGEPORT HOSPITAL

OWNER

**PARK AVENUE CAMPUS
OUTPATIENT CENTER**
5520 Park Avenue
Trumbull, CT 06611

**GARDEN LEVEL PLAN - DIMS
AND PARTITION TYPES**

DRAWING TITLE

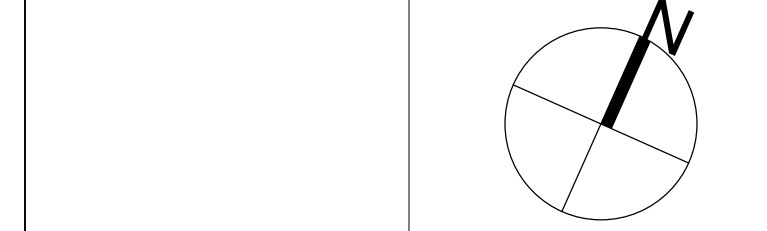

SCALE As indicated DATE JULY 12, 2013

JOB NUMBER 4512.001

DRAWN HCE CHECKED Checker

CONSTRUCTION DOCUMENTS

**A100a
EAST**

DRAWING NUMBER

